

# CONSTRUCTION PLANS

## PV GROUND MOUNT PHOTOVOLTAIC SYSTEM

### 5,804.88 KW-DC

### SHUTESBURY, MA 01072

**SOLAR INTEGRATOR:**

CONTI ENTERPRISES, INC  
 2045 LINCOLN HWY,  
 EDISON, NJ 08817  
 P: 732-520-5000  
 CONTACT: SEAN HARRINGTON

**PROPERTY INFO:**

PRATT CORNER ROAD,  
 SHUTESBURY,  
 MASSACHUSETTS 01072

**ENGINEERING FIRMS:**

ENGINEER OF RECORD:  
 POWER ENGINEERS LLC  
 37 FOX DEN ROAD,  
 KINGSTON, MA 02364  
 P: 508-612-0382  
 CONTACT: DAVE COLOMBO, P.E. #40426

**SYSTEM OWNER:**

LSDP 12, LLC  
 180 NORTH STETSON AVENUE,  
 35TH FLOOR, SUITE 3500  
 CHICAGO, IL 60601  
 P: 312-576-5678  
 CONTACT: MARNIN LEBOVITS

|     |          |      |    |
|-----|----------|------|----|
| NO. | REVISION | DATE | BY |
|     |          |      |    |
|     |          |      |    |
|     |          |      |    |
|     |          |      |    |
|     |          |      |    |
|     |          |      |    |



SYSTEM OWNER

PROJECT NAME AND ADDRESS

SHUTESBURY GROUND MOUNT  
 PRATT CORNER RD AND REED  
 RD, SHUTESBURY, MA 01072

SHEET TITLE

TITLE SHEET

DRAWER  
 EDGAR PUESAN

PROJECT NO.  
 1620400


DESIGN DATE  
 10/04/2016

SCALE  
 AS NOTED

T-100

#### CONTI CIVIL & ELECTRICAL DRAWING LIST

| SHEET # | SHEET NAME                    | REV. | DATE       |
|---------|-------------------------------|------|------------|
| T-100   | TITLE SHEET                   | 0    | 12/05/2016 |
| G-001   | GENERAL NOTES SHEET 1         | 0    | 12/05/2016 |
| G-002   | GENERAL NOTES SHEET 2         | 0    | 12/05/2016 |
| C-001   | OVERALL SITE PLAN             | 0    | 12/05/2016 |
| C-100   | FENCE AND GATES DETAILS       | 0    | 12/05/2016 |
| E-001   | PV SITE PLAN                  | 0    | 12/05/2016 |
| E-100   | AC ONE LINE DIAGRAM SHEET 1   | 0    | 12/05/2016 |
| E-101   | AC ONE LINE DIAGRAM SHEET 2   | 0    | 12/05/2016 |
| E-110   | DC ONE LINE DIAGRAM           | 0    | 12/05/2016 |
| E-111   | DC WIRING SCHEDULE SHEET 1    | 0    | 12/05/2016 |
| E-112   | DC WIRING SCHEDULE SHEET 2    | 0    | 12/05/2016 |
| E-200   | OVERALL DC FEEDER PLAN        | 0    | 12/05/2016 |
| E-201   | DC FEEDER PLAN SHEET 1        | 0    | 12/05/2016 |
| E-202   | DC FEEDER PLAN SHEET 2        | 0    | 12/05/2016 |
| E-203   | DC FEEDER PLAN SHEET 3        | 0    | 12/05/2016 |
| E-204   | DC FEEDER PLAN SHEET 4        | 0    | 12/05/2016 |
| E-210   | OVERALL DC STRING WIRING PLAN | 0    | 12/05/2016 |
| E-211   | DC STRING WIRING SHEET 1      | 0    | 12/05/2016 |
| E-212   | DC STRING WIRING SHEET 2      | 0    | 12/05/2016 |
| E-213   | DC STRING WIRING SHEET 3      | 0    | 12/05/2016 |
| E-214   | DC STRING WIRING SHEET 4      | 0    | 12/05/2016 |
| E-300   | GROUNDING DETAILS SHEET 1     | 0    | 12/05/2016 |
| E-301   | GROUNDING DETAILS SHEET 2     | 0    | 12/05/2016 |
| E-302   | GROUNDING DETAILS SHEET 3     | 0    | 12/05/2016 |
| E-400   | EQUIPMENT PAD DETAIL          | 0    | 12/05/2016 |
| E-401   | MISCELLANEOUS DETAILS SHEET 1 | 0    | 12/05/2016 |
| E-402   | MISCELLANEOUS DETAILS SHEET 2 | 0    | 12/05/2016 |
| E-403   | MISCELLANEOUS DETAILS SHEET 3 | 0    | 12/05/2016 |
| E-404   | MISCELLANEOUS DETAILS SHEET 4 | 0    | 12/05/2016 |
| E-405   | MISCELLANEOUS DETAILS SHEET 5 | 0    | 12/05/2016 |
| E-500   | WARNING LABELS SHEET 1        | 0    | 12/05/2016 |
| E-501   | WARNING LABELS SHEET 2        | 0    | 12/05/2016 |
| E-502   | WARNING LABELS SHEET 3        | 0    | 12/05/2016 |

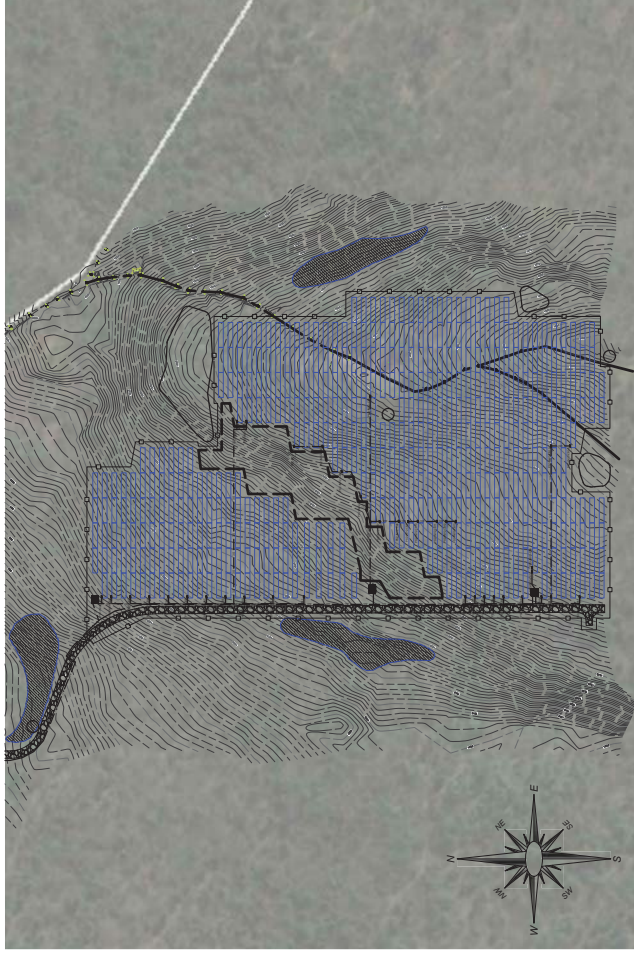

SITE PLAN



SCALE: 1" = 150'